



O.H.W.T. PLAN

ELEVATION - III
20_WD_04

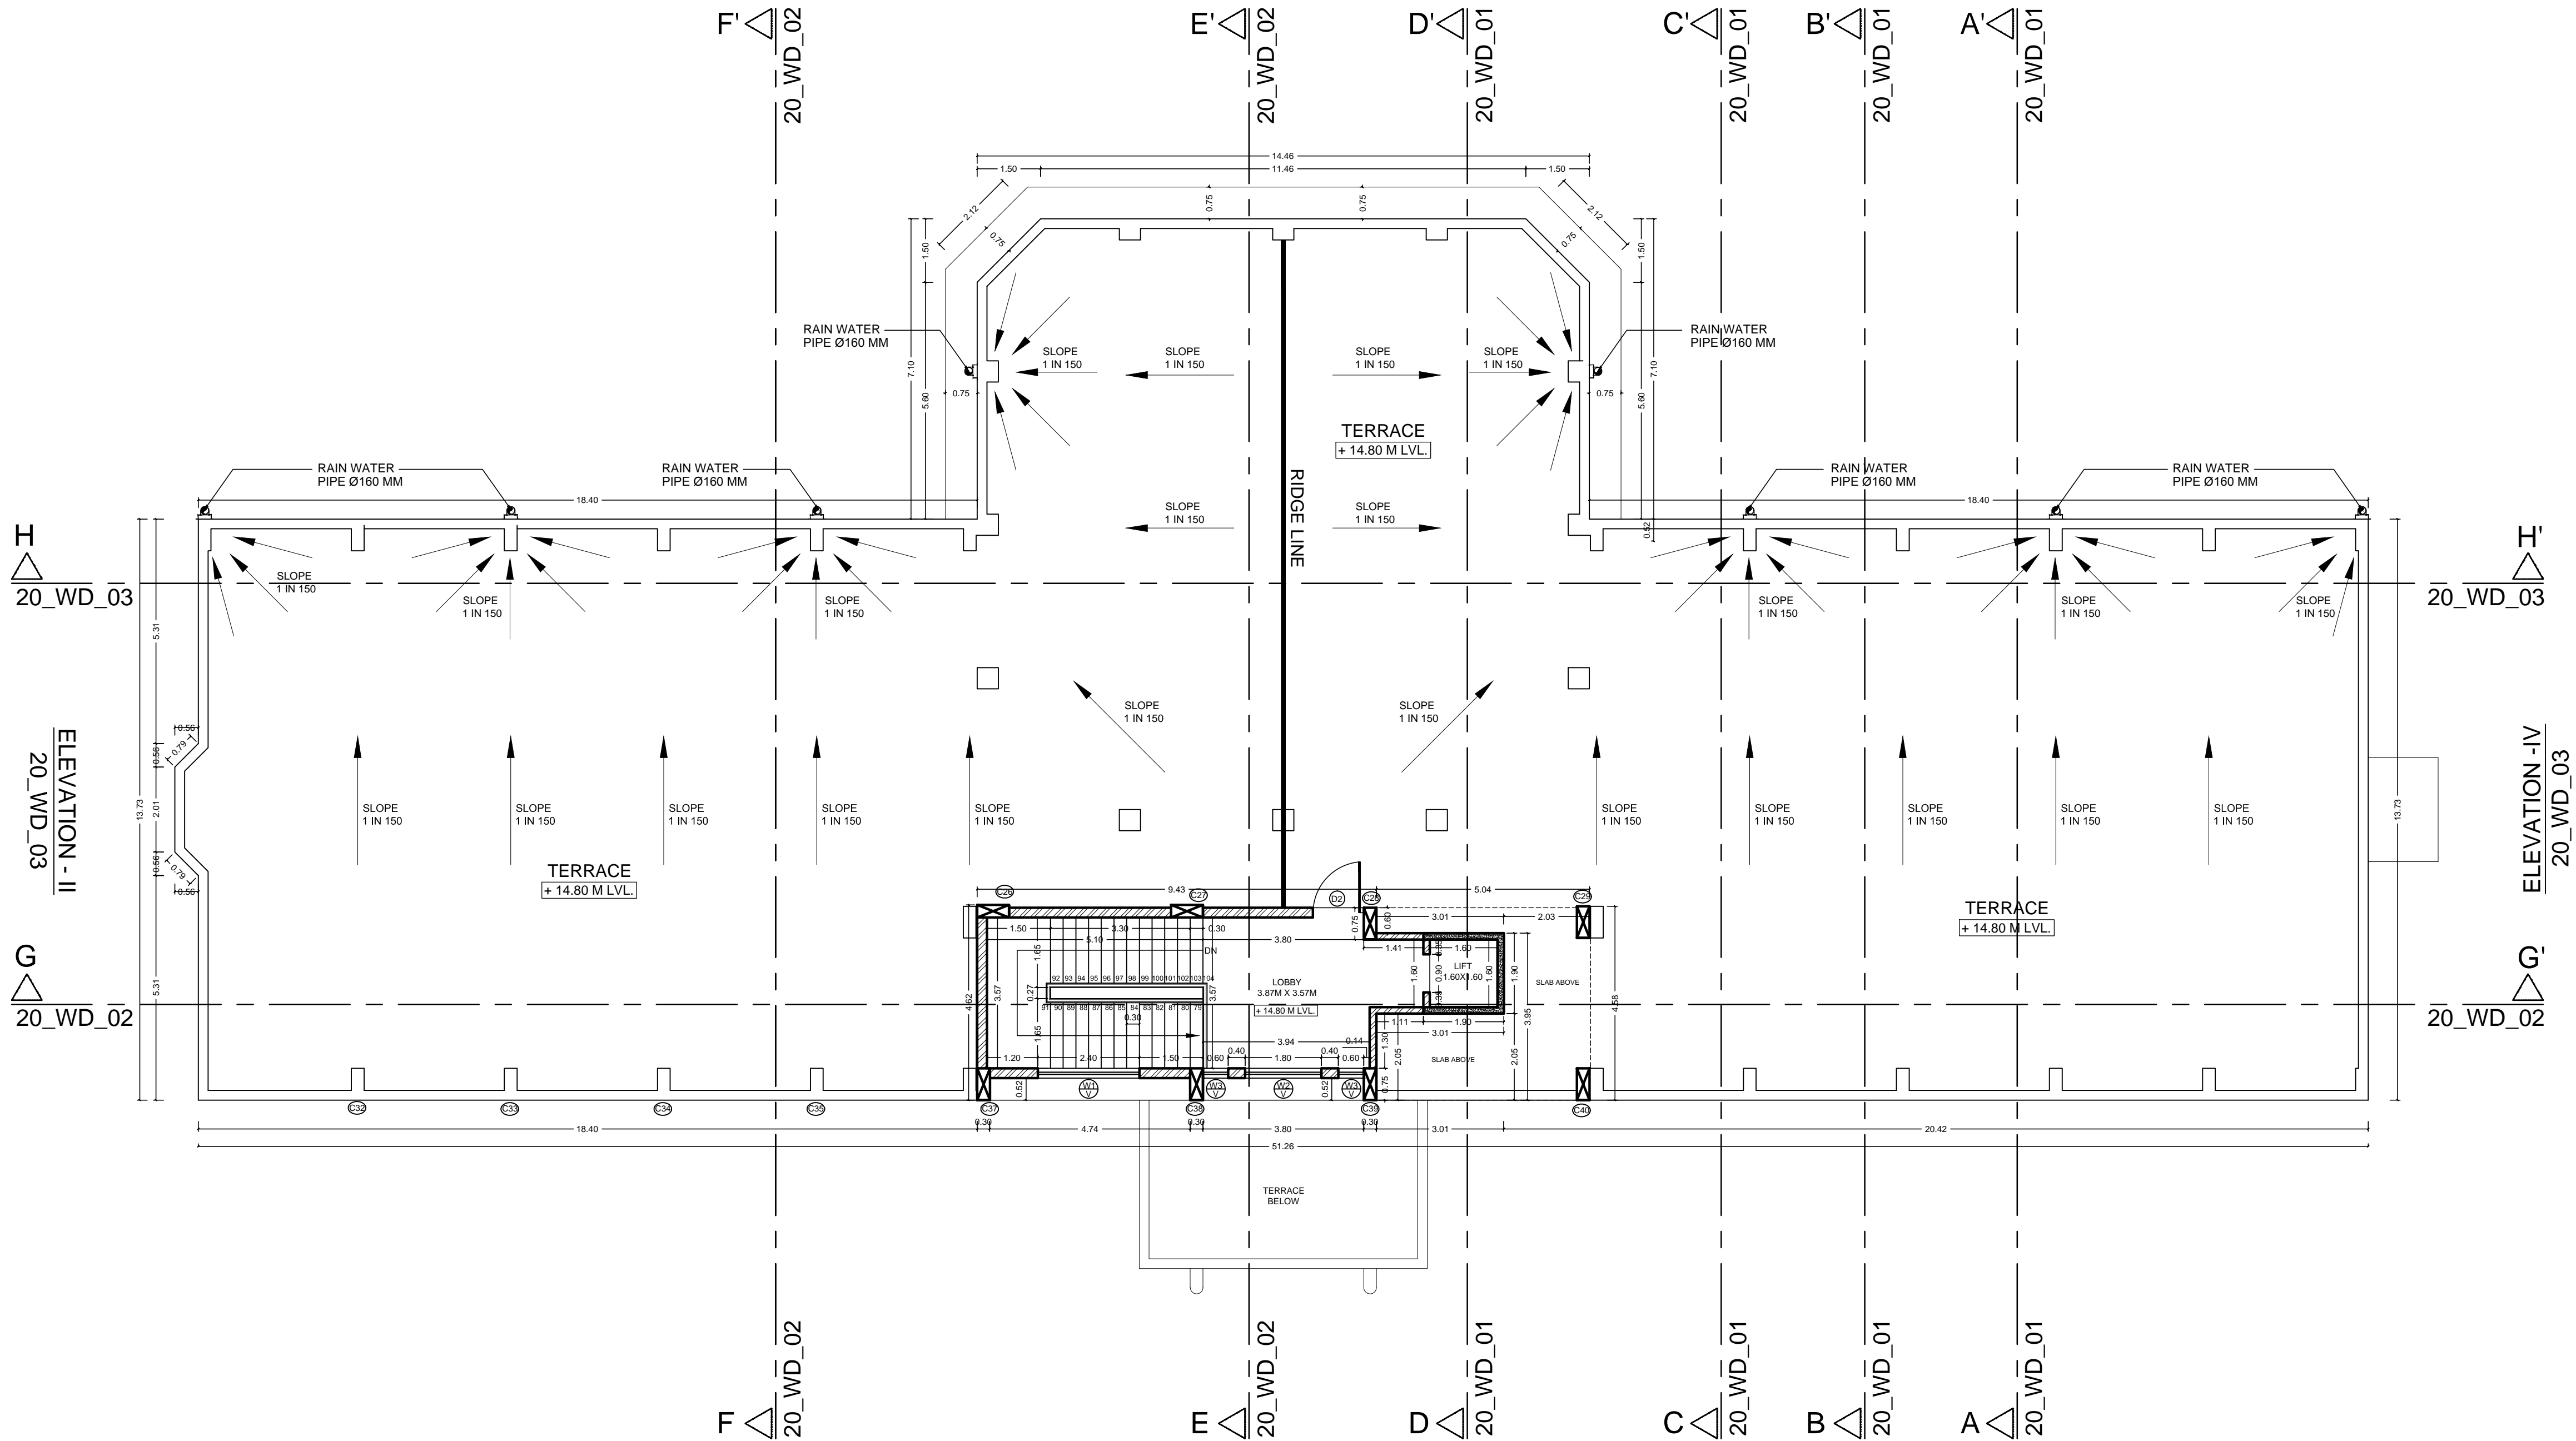

ELEVATION - I
20_WD_04

 TERRACE FLOOR PLAN



PRINT ISSUE: W. D. FOR TENDER

JOB NO.
A_150_2014

DRG.NO.
10_WD_05_Terrace Floor Plan

NOTES

THIS DRAWING IS THE SOLE PROPERTY OF AGORA DESIGNERS PVT.LTD. AND IS NOT TO BE REPRODUCED OR COPIED IN PART OR WHOLE OR IN ANY FORM.

- DO NOT SCALE FROM THIS DRAWING. ONLY WRITTEN DIMENSIONS ARE TO BE FOLLOWED.
- CONTRACTORS MUST CHECK AND VERIFY THE DRAWING BEFORE EXECUTION & IN CASE OF ANY DISCREPANCY MUST REPORT TO THE ARCHITECT.
- ARCHITECT WILL NOT BE RESPONSIBLE FOR ANY CHANGES ON SITE WITHOUT HIS CONCERN.
- FOR STRUCTURAL ELEMENTS & OTHER SERVICES REFER DRAWINGS FROM RESPECTIVE CONSULTANTS.

TERRACE FLOOR SCHEDULE OF OPENINGS

DOORS:-

SR. NO.	TYPE	SIZE OF OPENING	SILL HEIGHT	LINTEL HEIGHT	TOTAL DOORS
1.	D2	1.20M x 2.10M	---	2.10M	01

WINDOWS:-

6.	W1 V	2.40M x 1.35M 2.40M x 0.50M	0.90M	2.75M	01
5.	W2 V	1.80M x 1.35M 1.80M x 0.50M	0.90M	2.75M	01
6.	W3 V	0.60M x 1.35M 0.60M x 0.50M	0.90M	2.75M	02

LEGEND :-

	RAIN WATER PIPE
	4" WIDE SS GUTTER WITH GRATING
	RIDGE LINE

PROJECT

PROPOSED EXTENSION FOR POST GRADUATION BUILDING, SNTD WOMEN'S UNIVERSITY PUNE CAMPUS, PUNE.

DRAWING TITLE : TENDER DRAWING

TERRACE FLOOR PLAN WITH DETAILS OF WATER DOWNTAKE

AGORA DESIGNERS PVT. LTD.

ARCHITECTS, LANDSCAPE AND INTERIOR DESIGNERS

1249/50, 3rd FL. ABOVE GREETWELL SHOP, DECCAN GYMKHANA, SHIVAJI NAGAR, PUNE. 411004
PH. 020 25539631 / 25530715 MOBILE: 91 9822268058 / 9423582087
E-MAIL: agora.designers@gmail.com

SCALE	DATE	DRAWN BY	DEALT	CHECKED
1 : 100 @A1	25-07-18	AR. SANDEEP	AR. SANDEEP	

APPROVED BY : AR. AVINASH HAVAL
REG.NO. = CA/86/10025

NORTH :



PATH : (SYSTEM-08)D:\AGORA PROJECTS\01-ARCHITECTURAL PROJECTS\01-CURRENT PROJECTS\A_150_2014_SNTD PG BUILDING\02_WORKING DRAWING\12-PLANS\01-CURRENT REV. DRGS