


THIRD FLOOR PLAN  
ELECTRICAL LAYOUT

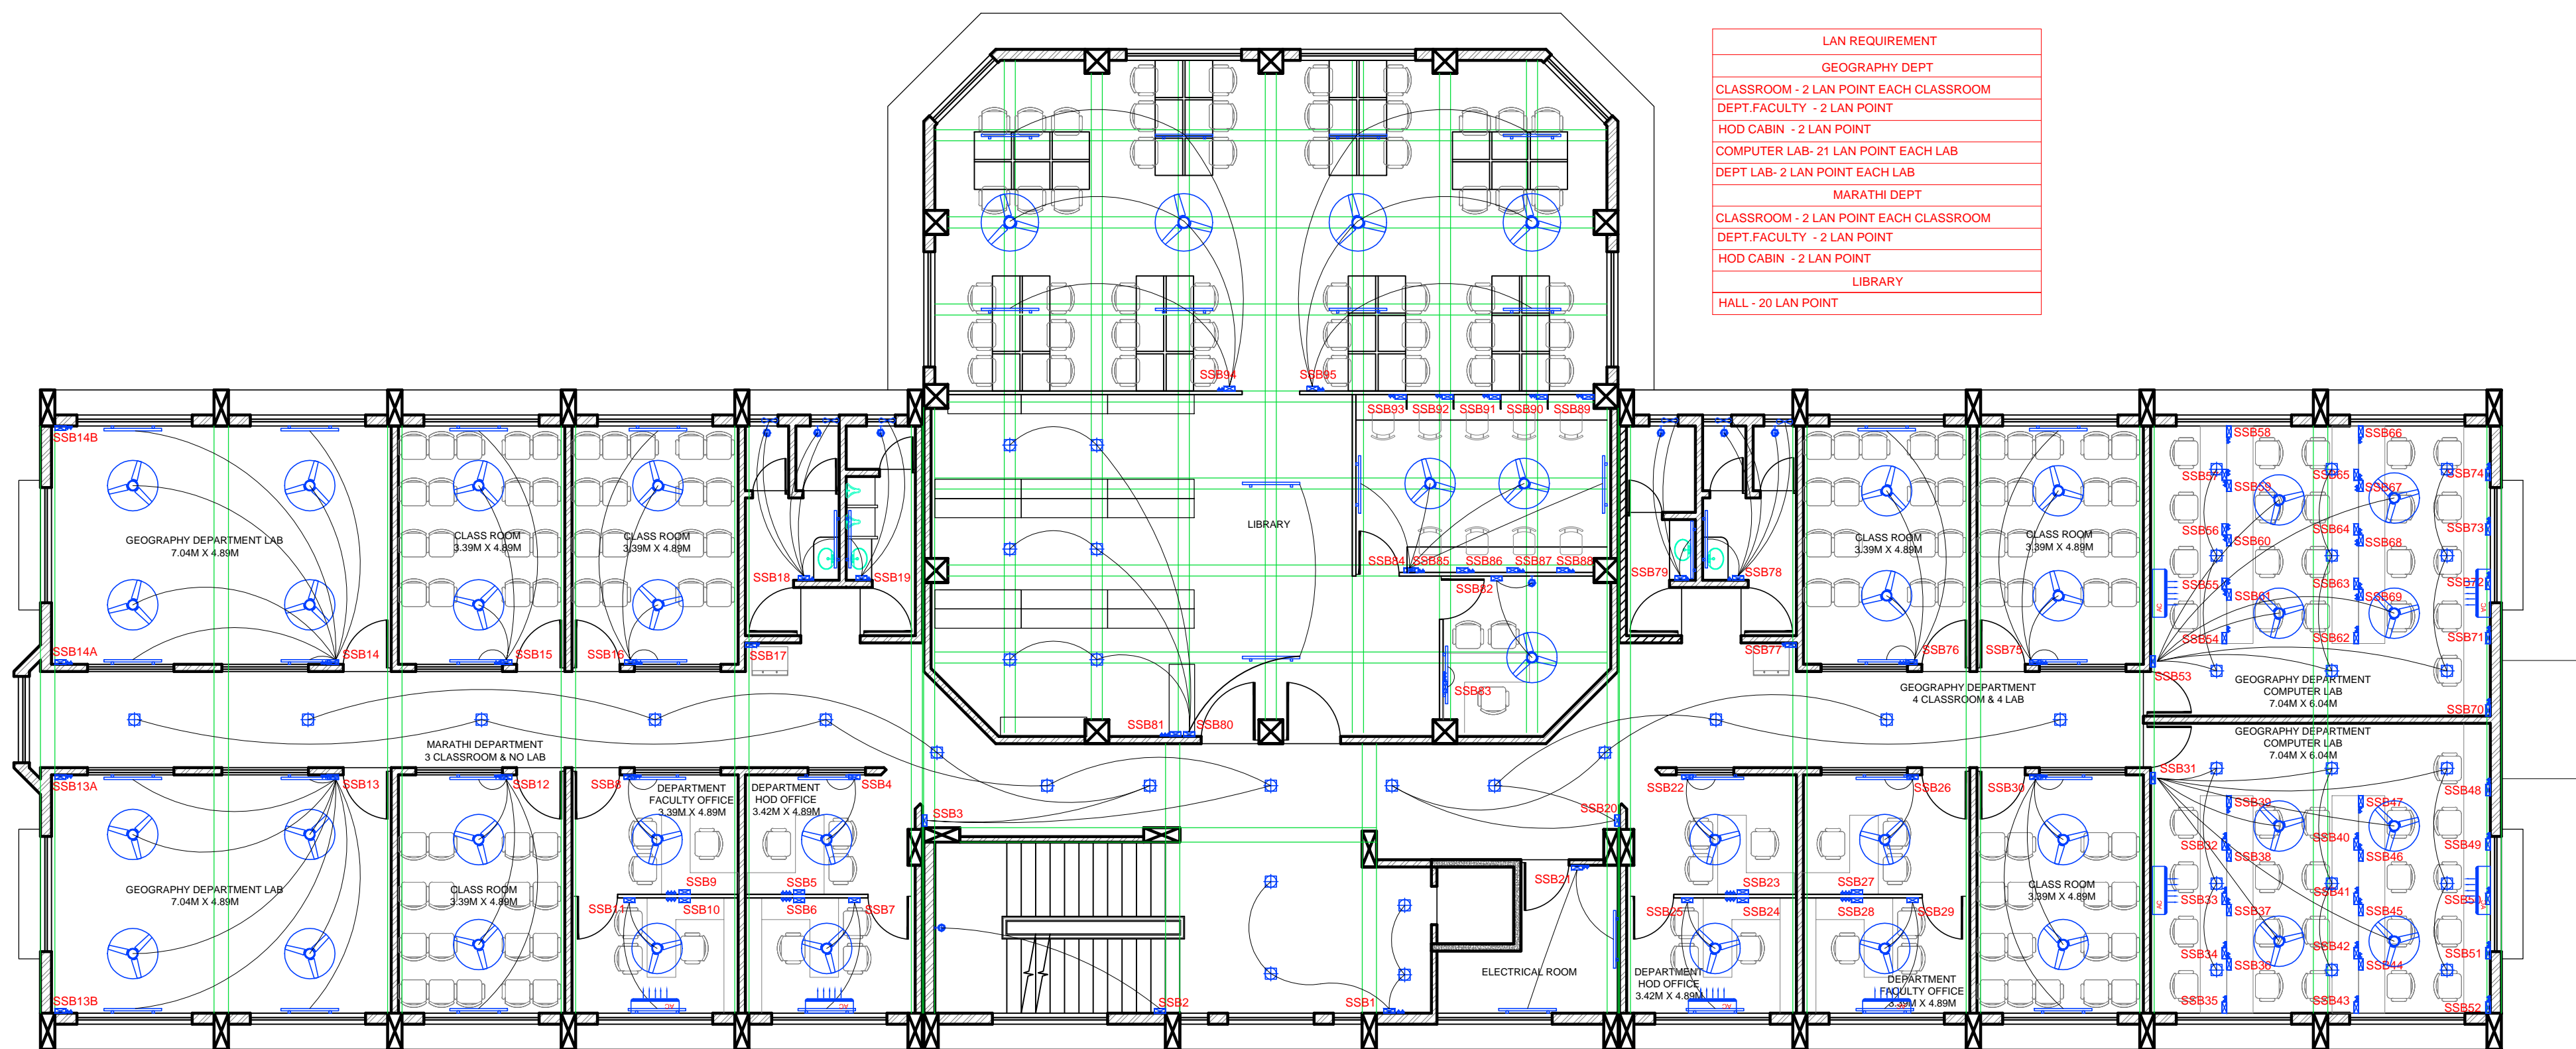

SECOND FLOOR PLAN  
ELECTRICAL LAYOUT

LAN REQUIREMENT
DRAWING DEPT
CLASSROOM - 2 LAN POINT EACH CLASSROOM
DEPT.FACULTY - 2 LAN POINT
HOD CABIN - 2 LAN POINT
STUDIO- 2 LAN POINT EACH STUDIO
MUSIC DEPT
CLASSROOM - 2 LAN POINT EACH CLASSROOM
DEPT.FACULTY - 2 LAN POINT
HOD CABIN - 2 LAN POINT
STUDIO- 2 LAN POINT EACH STUDIO
LAB- 5 LAN POINT
MULTIPURPOSE HALL
HALL - 2 LAN POINT

LAN REQUIREMENT
GEOGRAPHY DEPT
CLASSROOM - 2 LAN POINT EACH CLASSROOM
DEPT.FACULTY - 2 LAN POINT
HOD CABIN - 2 LAN POINT
COMPUTER LAB- 21 LAN POINT EACH LAB
DEPT LAB- 2 LAN POINT EACH LAB
MARATHI DEPT
CLASSROOM - 2 LAN POINT EACH CLASSROOM
DEPT.FACULTY - 2 LAN POINT
HOD CABIN - 2 LAN POINT
LIBRARY
HALL - 20 LAN POINT

PRINT ISSUE: TENDER DRAWING

JOB NO. A_150_2014	DRG.NO. : 50_EL_02
-----------------------	-----------------------

NOTES

- THIS DRAWING IS THE SOLE PROPERTY OF AGORA DESIGNERS PVT.LTD. AND IS NOT TO BE REPRODUCED OR COPIED IN PART OR WHOLE OR IN ANY FORM.
- DO NOT SCALE FROM THIS DRAWING. ONLY WRITTEN DIMENSIONS ARE TO BE FOLLOWED.
  - CONTRACTORS MUST CHECK AND VERIFY THE DRAWING BEFORE EXECUTION & IN CASE OF ANY DISCREPANCY MUST REPORT TO THE ARCHITECT.
  - ARCHITECT WILL NOT BE RESPONSIBLE FOR ANY CHANGES ON SITE WITHOUT HIS CONCERN.
  - FOR STRUCTURAL ELEMENTS & OTHER SERVICES REFER DRAWINGS FROM RESPECTIVE CONSULTANTS.

LEGENDS

		HEIGHT
	SWITCHBOARD	
	6 AMP PLUG PT	
	SURFACE LIGHT FITTING	
	TUBE	2.75 MT
	WALL POINT	2.75 MT
	CEILING FAN	
	EXHAUST FAN	
	AC	2.75 MT
	LED FITTING OUTDOOR	

NOTES

- REFER DRG. NO. 40\_WD/00 FOR SCHEDULE OF ALL OPENIGS
- REFER DRG. NO. 10\_WD/01 TO 05 FOR FOR LAYOUTS
- ALL DIMENTIONS ARE IN MM
- COLORDED PRINTING IS ADVISABLE FOR BETTER UNDERSTANDING OF DRG

ISSUE OF PRINTS

CLIENT	CONT.	OTHERS	DATE
01	—	—	27-08-2014

REVISIONS

NO.	DATE	DESCRIPTION
R0	00.00.00	

PROJECT

PROPOSED EXTENSION FOR POST GRADUATION BUILDING, SNTD WOMEN'S UNIVERSITY, PUNE CAMPUS, PUNE.

DRAWING TITLE : TENDER DRAWING

ELECTRICAL LAYOUT SECOND & THIRD FLOOR

**AGORA DESIGNERS PVT. LTD.**  
ARCHITECTS, LANDSCAPE AND INTERIOR DESIGNERS  
1249/50, 3rd FL. ABOVE GREETWELL SHOP, DECCAN GYMKHANA, SHIVAJI NAGAR, PUNE. 411004  
PH. 020 25539631 / 25530715 MOBILE: 91 9822268058 / 9423582087  
E-MAIL: agora.designers@gmail.com

SCALE	DATE	DRAWN BY	DEALT	CHECKED
1 : 100 @A1	25-07-18	ID. APURVA	AR. SANDEEP	AR. SANDEEP
APPROVED BY : AR. AVINASH HAVAL REG.NO. = CA/86/10025				NORTH :

PATH : comp. 6 / D: Agora Projects : Architectural Projects : A\_109\_2014\_SNDT