


FIRST FLOOR PLAN
ELECTRICAL LAYOUT

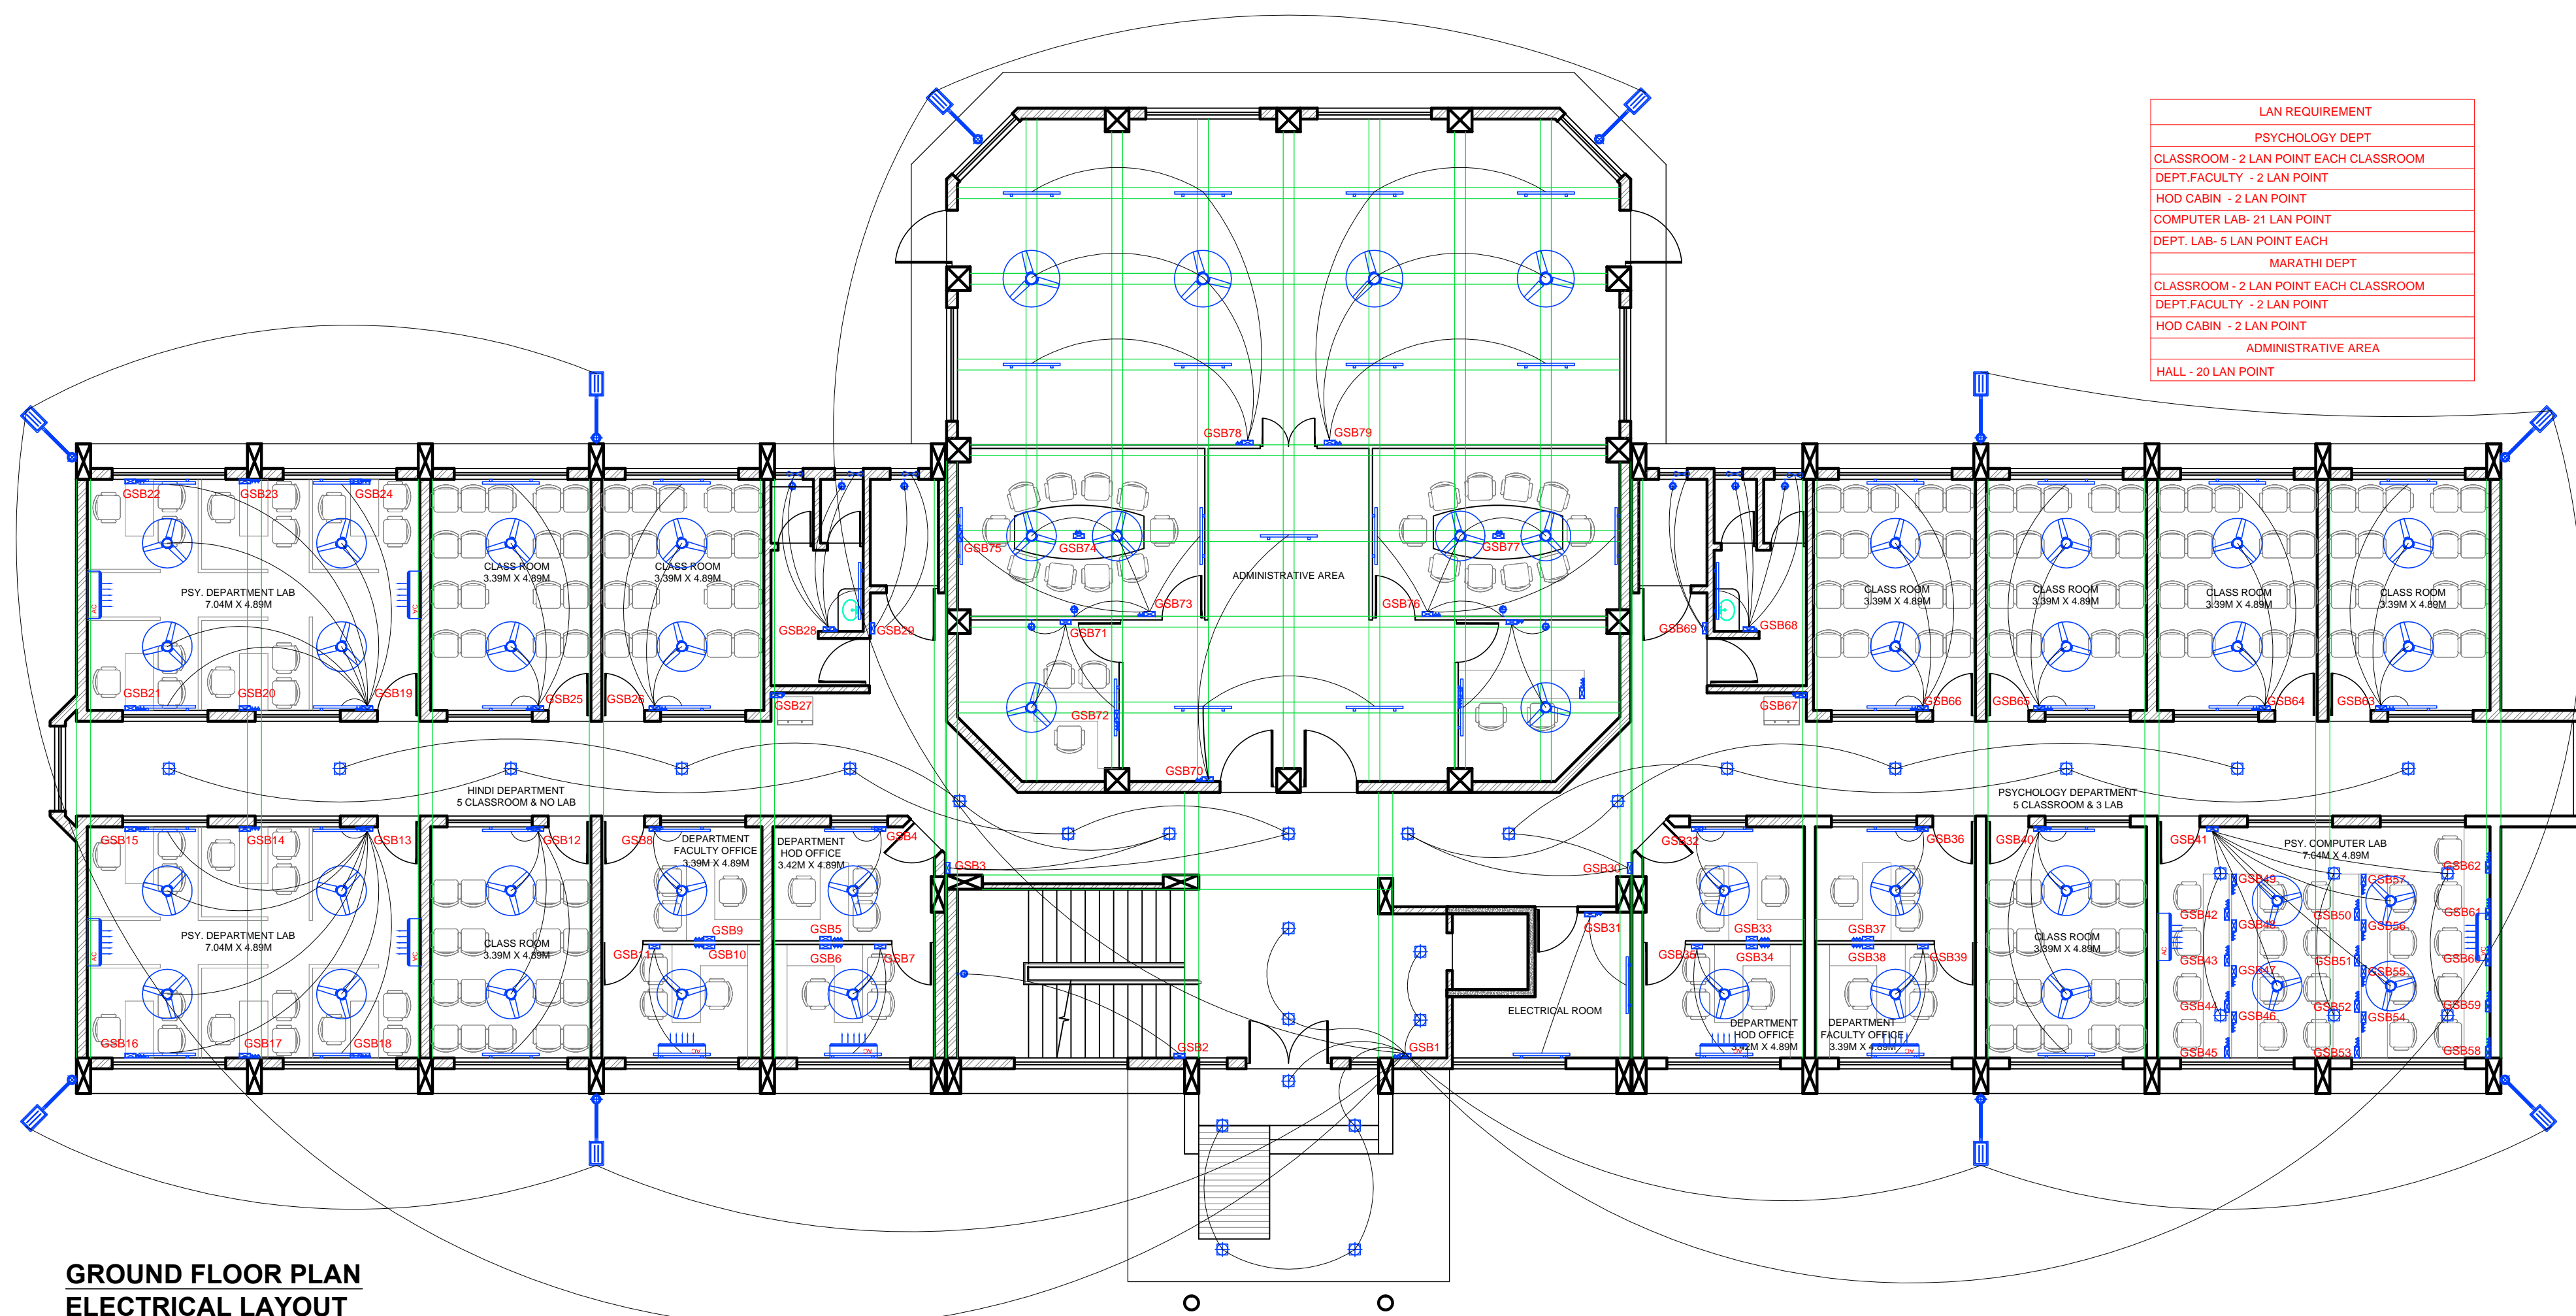

GROUND FLOOR PLAN
ELECTRICAL LAYOUT

PRINT ISSUE: TENDER DRAWING

JOB NO. : A_150_2014
DRG.NO. : 50_EL_01

- NOTES
- THIS DRAWING IS THE SOLE PROPERTY OF AGORA DESIGNERS PVT.LTD. AND IS NOT TO BE REPRODUCED OR COPIED IN PART OR WHOLE OR IN ANY FORM.
- DO NOT SCALE FROM THIS DRAWING. ONLY WRITTEN DIMENSIONS ARE TO BE FOLLOWED.
 - CONTRACTORS MUST CHECK AND VERIFY THE DRAWING BEFORE EXECUTION & IN CASE OF ANY DISCREPANCY MUST REPORT TO THE ARCHITECT.
 - ARCHITECT WILL NOT BE RESPONSIBLE FOR ANY CHANGES ON SITE WITHOUT HIS CONCERN.
 - FOR STRUCTURAL ELEMENTS & OTHER SERVICES REFER DRAWINGS FROM RESPECTIVE CONSULTANTS.

LEGENDS		HEIGHT
	SWITCHBOARD	
	6 AMP PLUG PT	
	SURFACE LIGHT FITTING	
	TUBE	2.75 MT
	WALL POINT	2.75 MT
	CEILING FAN	
	EXHAUST FAN	
	AC	2.75 MT
	LED FITTING OUTDOOR	

- NOTES
- REFER DRG. NO. 40_WD/00 FOR SCHEDULE OF ALL OPENIGS
 - REFER DRG. NO. 10_WD/01 TO 05 FOR LAYOUTS
 - ALL DIMENTIONS ARE IN MM
 - COLORDED PRINTING IS ADVISABLE FOR BETTER UNDERSTANDING OF DRG

ISSUE OF PRINTS			
CLIENT	CONT.	OTHERS	DATE
01	—	—	27-08-2014

REVISIONS		
NO.	DATE	DESCRIPTION
R0	00.00.00	

PROJECT

PROPOSED EXTENSION FOR POST GRADUATION BUILDING, SNTD WOMEN'S UNIVERSITY, PUNE CAMPUS, PUNE.

DRAWING TITLE : TENDER DRAWING

ELECTRICAL LAYOUT GROUND & FIRST FLOOR

AGORA DESIGNERS PVT. LTD.
ARCHITECTS, LANDSCAPE AND INTERIOR DESIGNERS

1249/50, 3rd FL. ABOVE GREETWELL SHOP, DECCAN GYMKHANA, SHIVAJI NAGAR, PUNE. 411004
PH: 020 25539631 / 25530715 MOBILE: 91 9822268058 / 9423582087
E-MAIL: agora.designers@gmail.com

SCALE	DATE	DRAWN BY	DEALT	CHECKED
1 : 100 @A1	25-07-18	ID. APURVA	AR. SANDEEP	AR. SANDEEP

APPROVED BY : AR. AVINASH HAVAL
REG.NO. = CA/86/10025

NORTH :

PATH : comp. 6 / D: Agora Projects : Architectural Projects : A_109_2014_SNDT